

DUNWODY/BEELAND, Architects, Inc.

300 Mulberry Street, Suite 604
Macon, Georgia 3201
F 478.743.8853
www.dunwodybeeland.com

Dunwody/Beeland, Architects, Inc.
This drawing may be utilized only for the purpose of constructing or installing the work shown thereon at the site of the work specified. Any other use of this drawing, including without limitation any reproduction or alteration of this drawing, without prior written approval of Dunwody/Beeland, Architects, Inc. is prohibited.


MACON HOTEL
682 CHERRY STREET
MACON, GEORGIA

Revisions:	
▲	01-23-20
▲	11-20-20
▲	04-14-21

Sheet Title:
Basement Plumbing Plan - Sewer

Project #: 1821 Date: 8/12/2019

P1.0

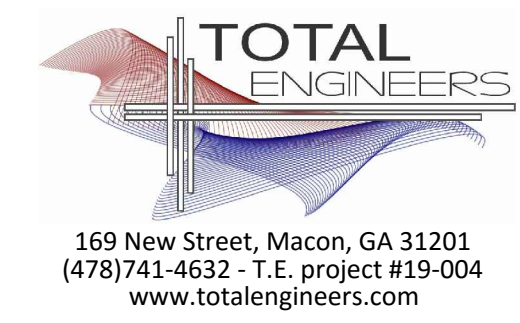

NOTES:

- FOR QUALITY HYDRATING ONLY.
- ALL PROCEPTOR UNITS ARE MANUFACTURED WITH THROU-ROOF FLASHINGS. PHYSICAL CHARACTERISTICS AND THICKNESS PROPERTIES SHALL BE AS SPECIFIED.
- UNITS SHALL BE INSTALLED IN ACCORDANCE WITH THE MANUFACTURER'S INSTALLATION INSTRUCTIONS.
- STAIRS SHALL BE INSTALLED IN ACCORDANCE WITH THE MANUFACTURER'S INSTALLATION INSTRUCTIONS.
- STAIRS SHALL BE INSTALLED IN ACCORDANCE WITH THE MANUFACTURER'S INSTALLATION INSTRUCTIONS.
- STAIRS SHALL BE INSTALLED IN ACCORDANCE WITH THE MANUFACTURER'S INSTALLATION INSTRUCTIONS.
- STAIRS SHALL BE INSTALLED IN ACCORDANCE WITH THE MANUFACTURER'S INSTALLATION INSTRUCTIONS.
- STAIRS SHALL BE INSTALLED IN ACCORDANCE WITH THE MANUFACTURER'S INSTALLATION INSTRUCTIONS.
- STAIRS SHALL BE INSTALLED IN ACCORDANCE WITH THE MANUFACTURER'S INSTALLATION INSTRUCTIONS.
- STAIRS SHALL BE INSTALLED IN ACCORDANCE WITH THE MANUFACTURER'S INSTALLATION INSTRUCTIONS.

REVISIONS:

NO.	DATE	DESCRIPTION
1	08/12/2019	ISSUE FOR PERMIT
2	08/12/2019	ISSUE FOR PERMIT

PROCEPTOR ZURN

MODEL: GMC 1500(2)

PROJECT: WD


DATE: 08/12/2019

DRAWN BY: F. CHAMBERLAIN

CHECKED BY: J. CHAMBERLAIN

SCALE: AS SHOWN


SHEET 1 OF 1

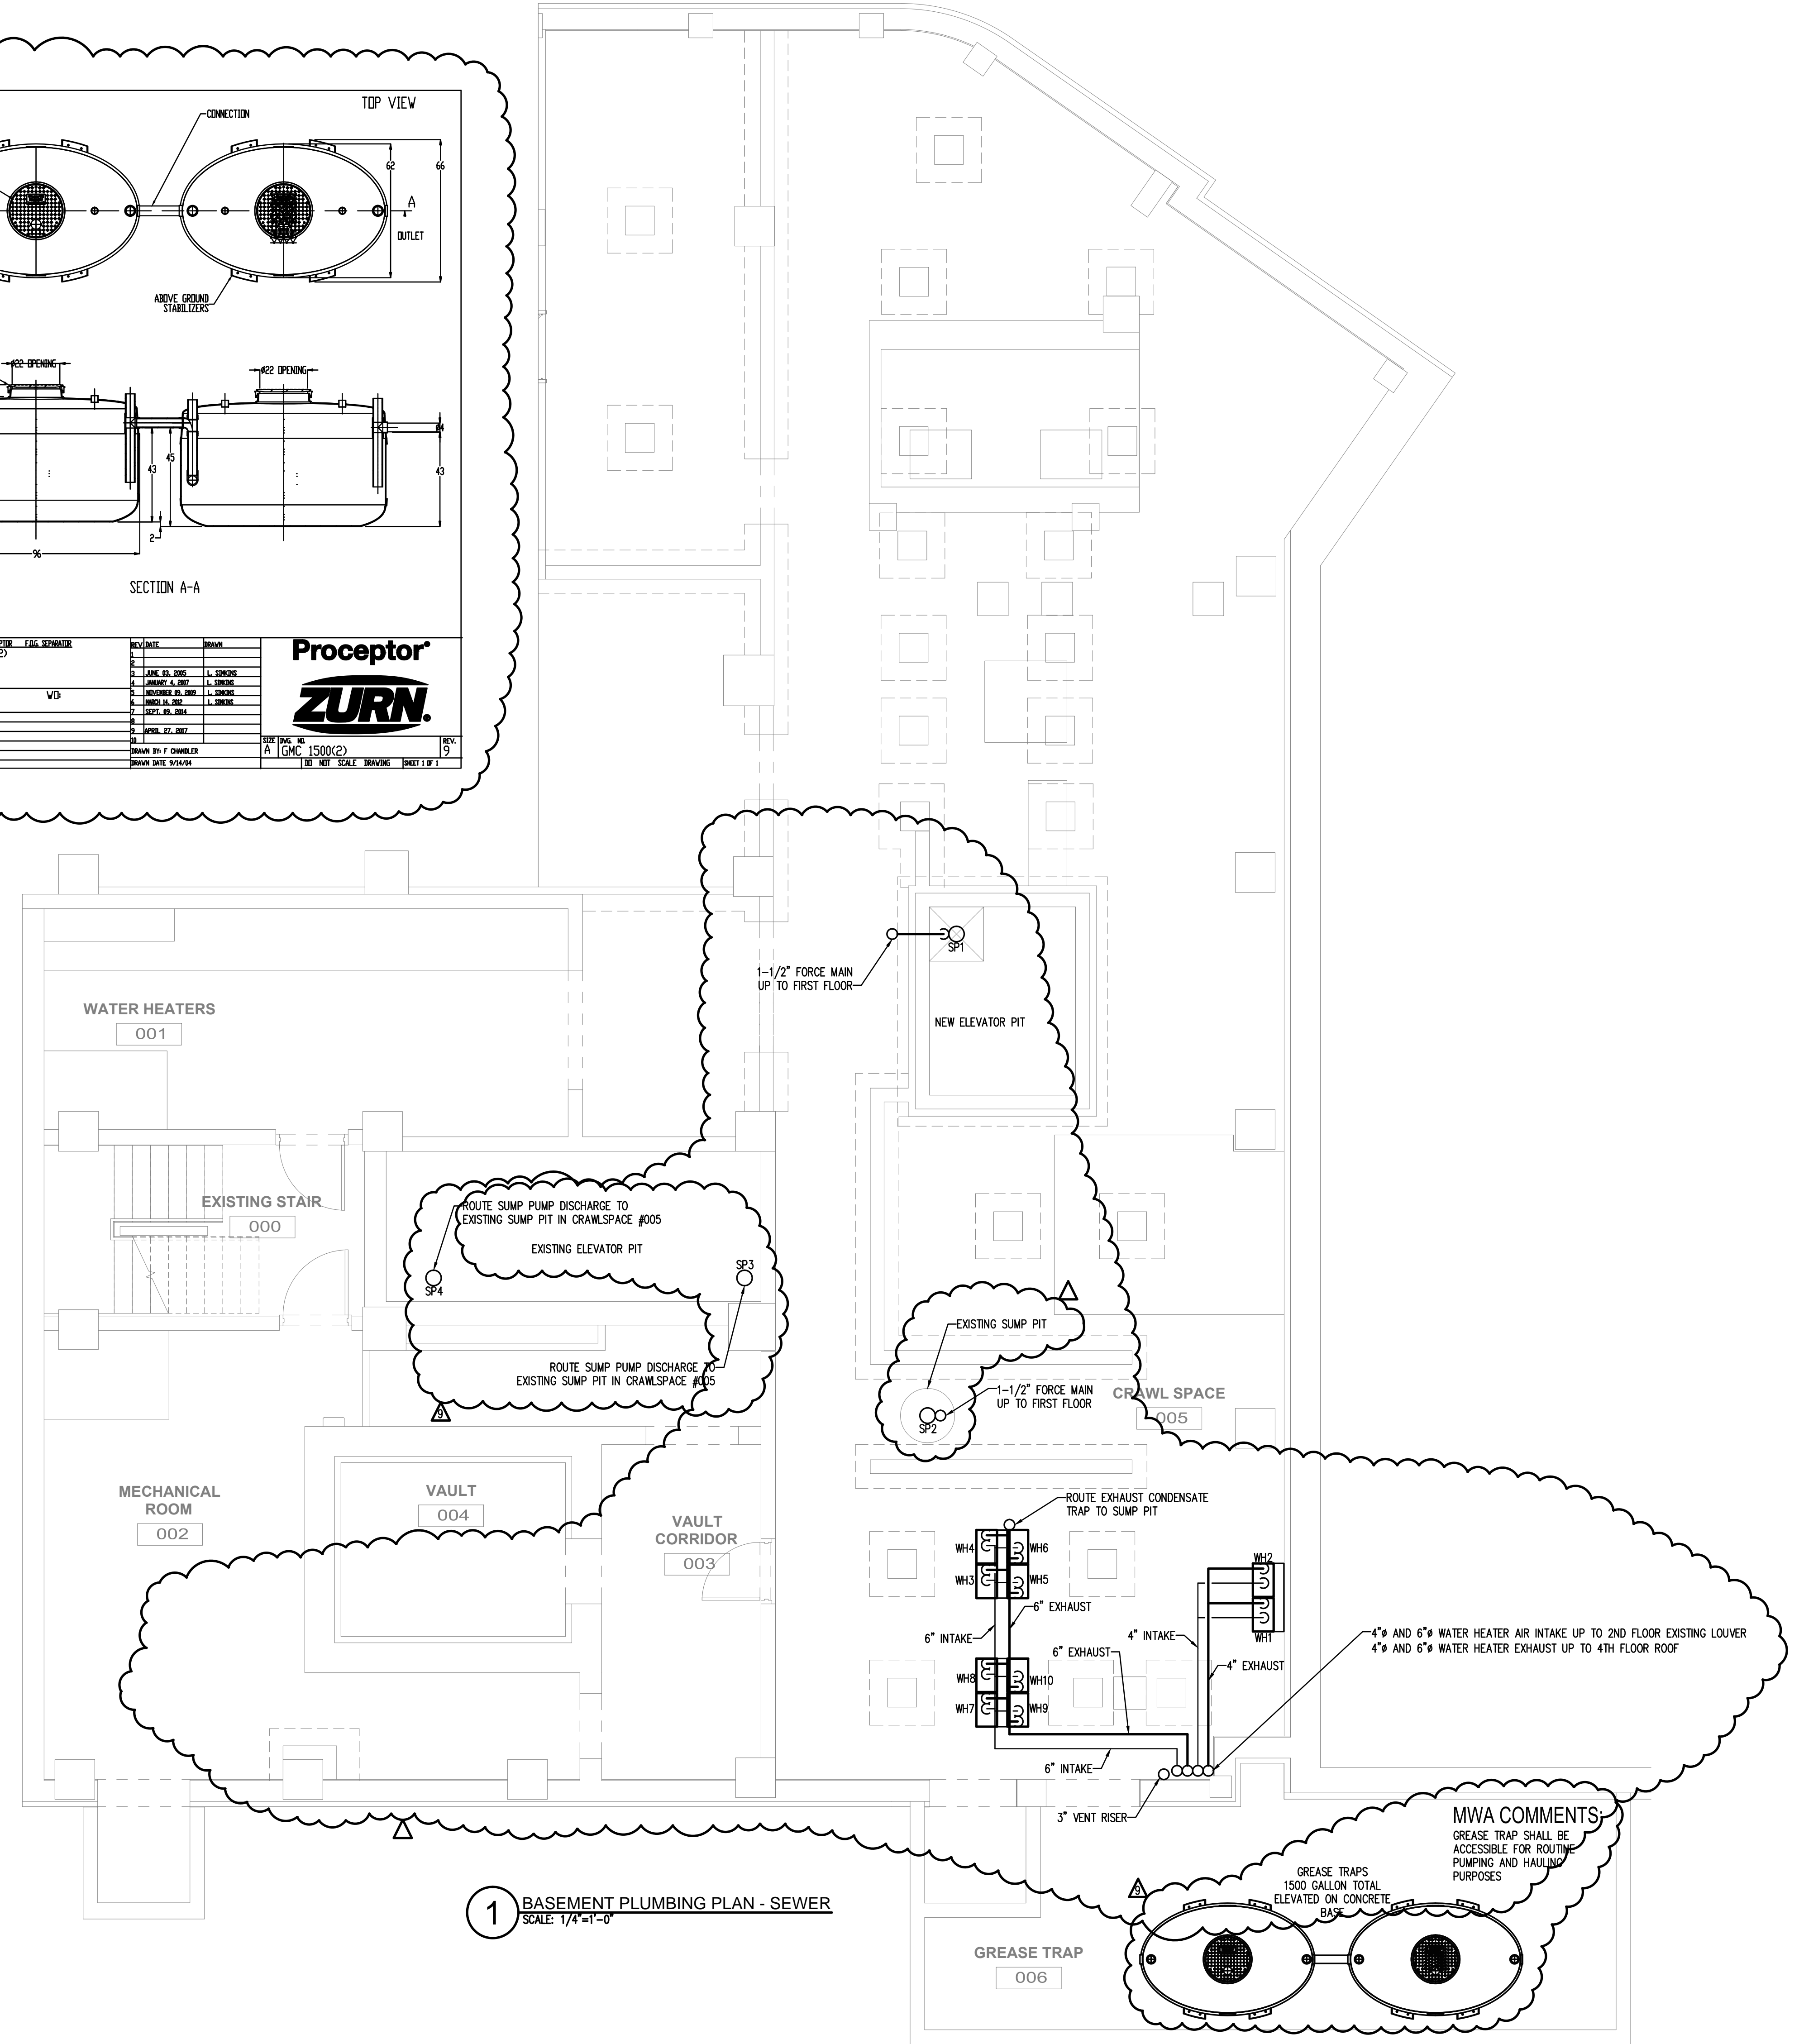


1 BASEMENT PLUMBING PLAN - SEWER
SCALE: 1/4"=1'-0"

MWA COMMENTS:
GREASE TRAP SHALL BE ACCESSIBLE FOR ROUTINE PUMPING AND HAULING PURPOSES


REFER TO P0.3 FOR MIXING VALVE PIPING SCHEMATIC

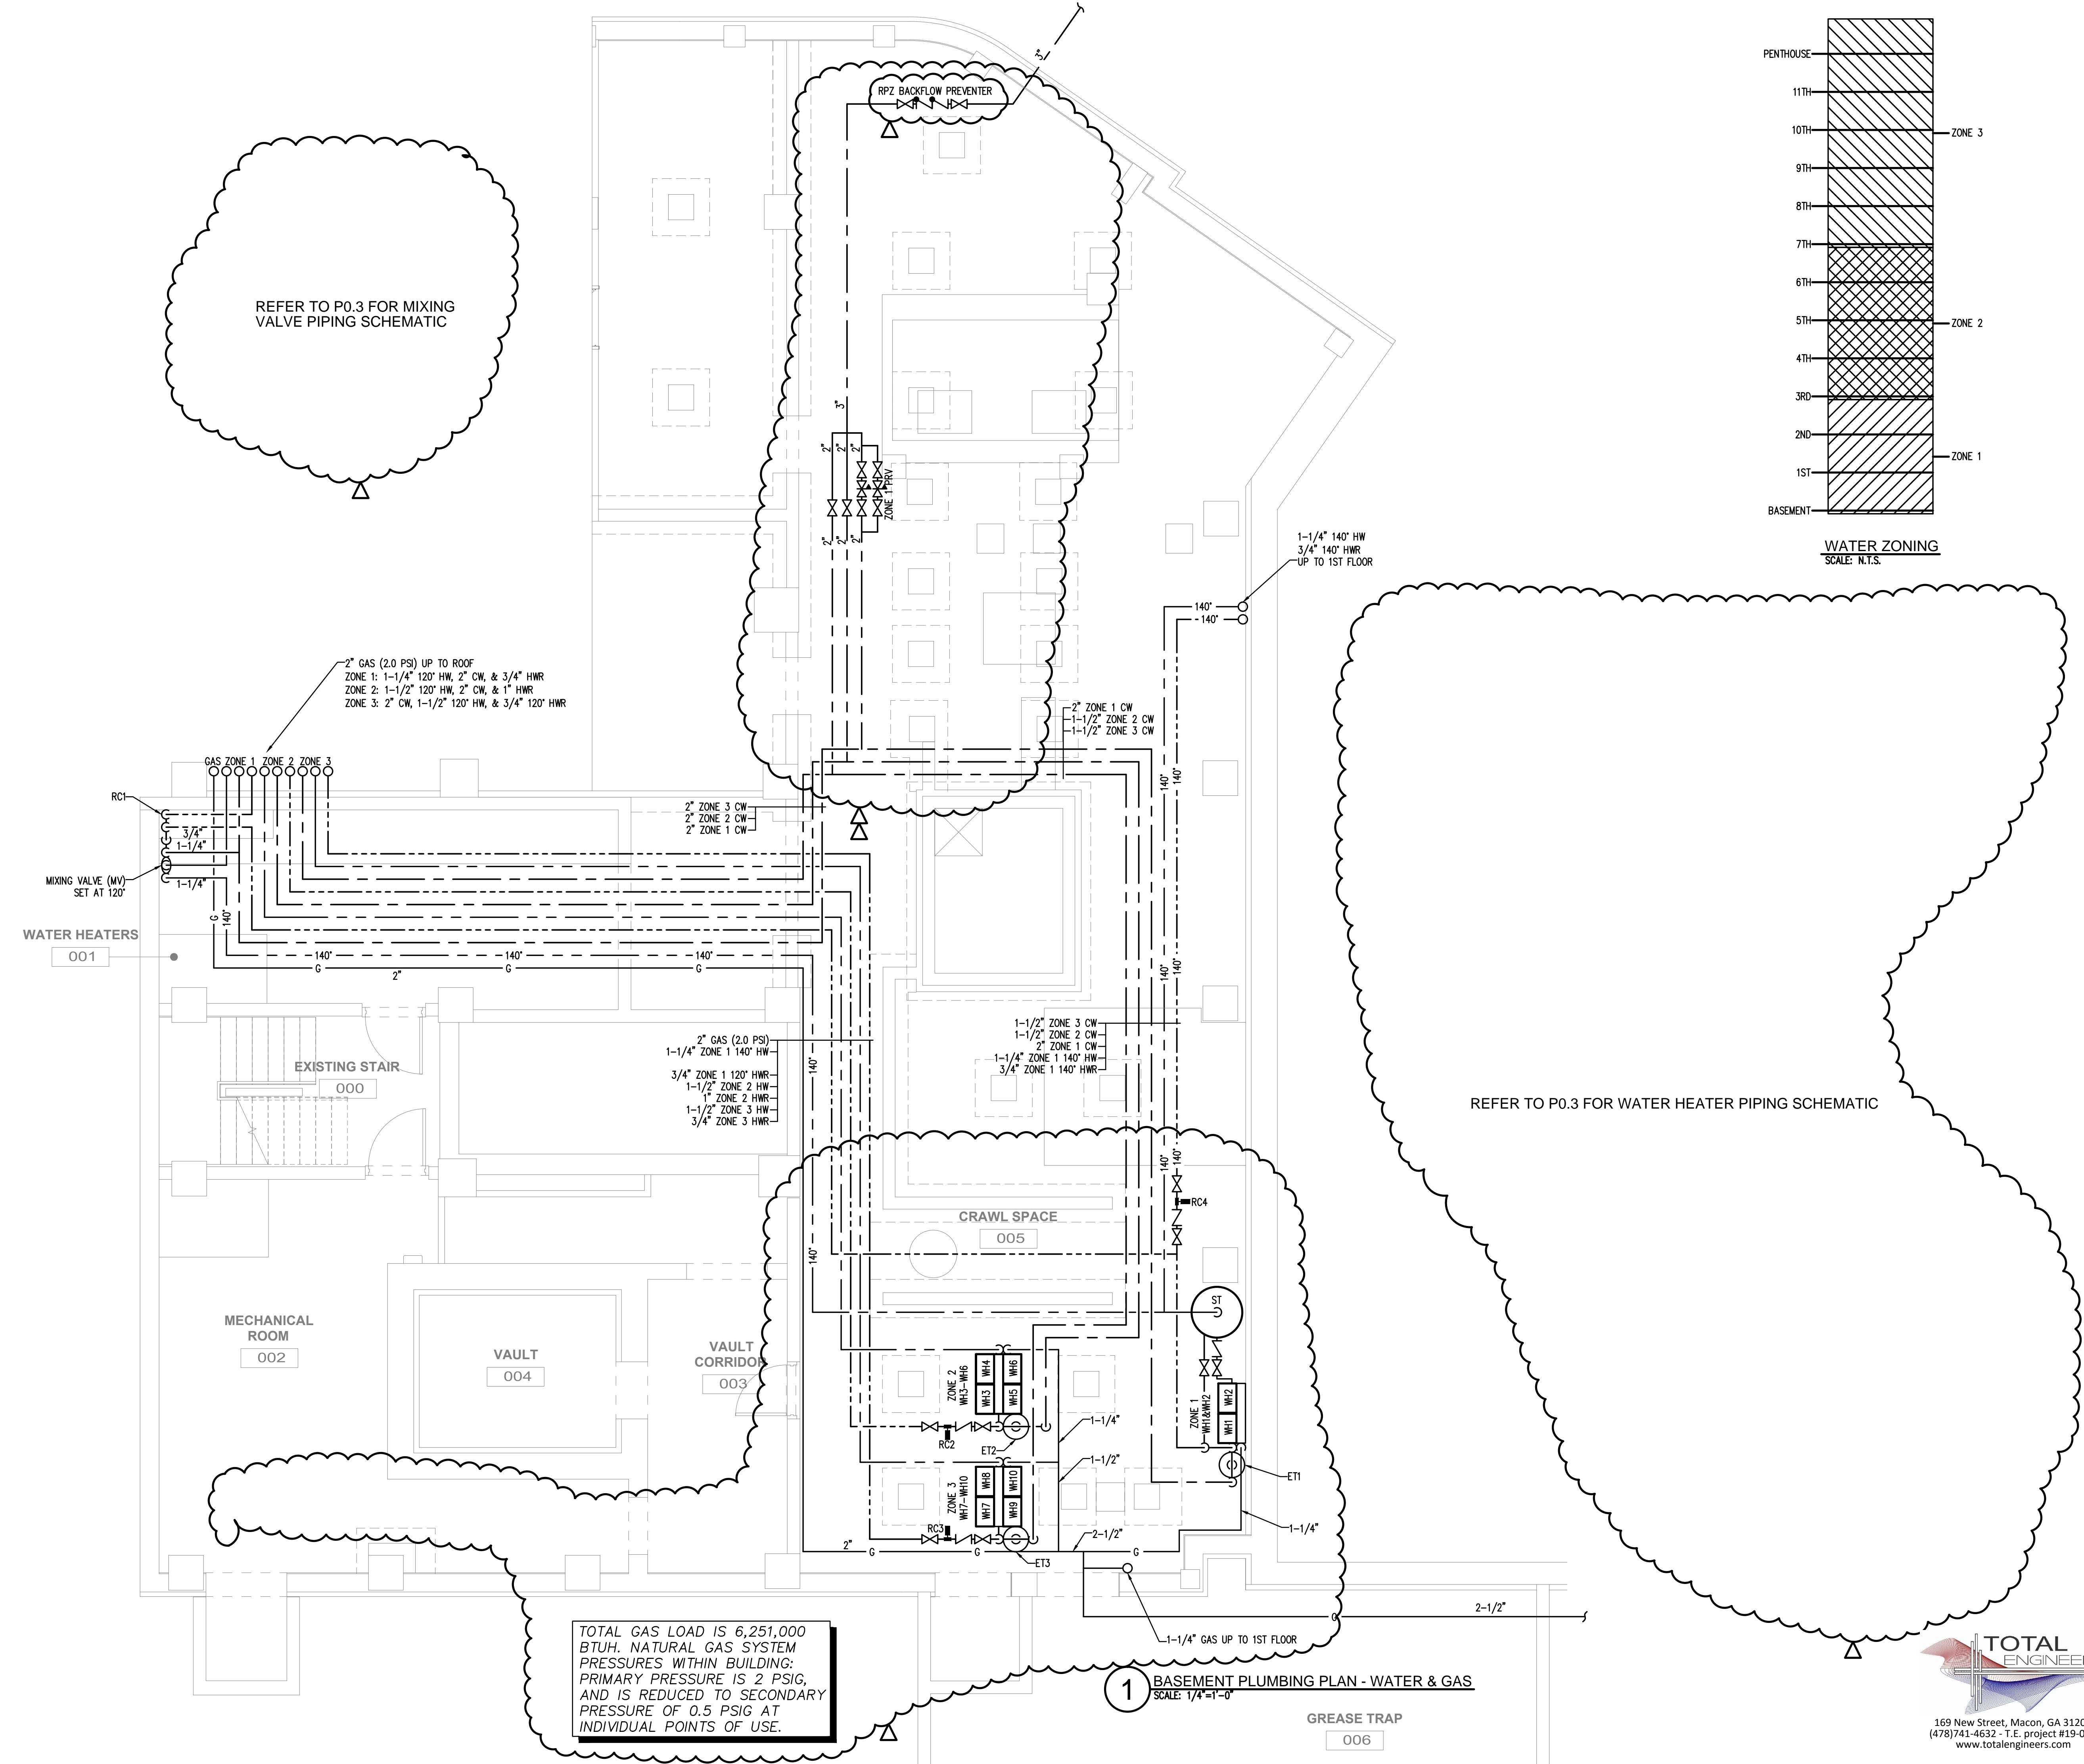

1 BASEMENT PLUMBING PLAN - WATER & GAS
SCALE: 1/4"=1'-0"

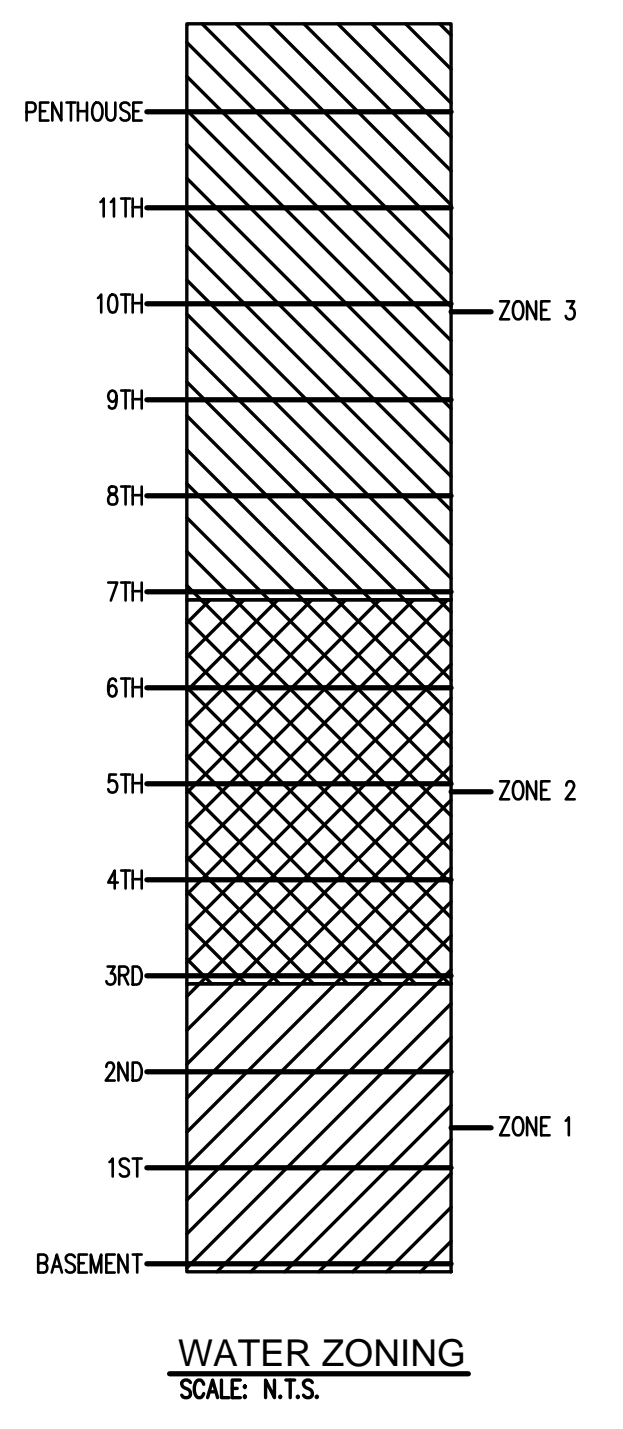

REFER TO P0.3 FOR WATER HEATER PIPING SCHEMATIC

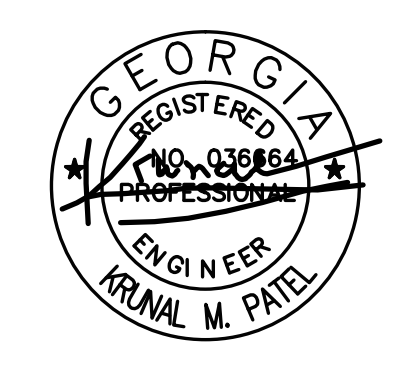

DUNWODY/BEELAND, Architects, Inc.

300 Mulberry Street, Suite 604
Macon, Georgia 31201
F 478.743.9853
www.dunwodybeeland.com


Dunwody/Beeland, Architects, Inc. This drawing may be utilized only for the purpose of constructing or installing the work shown thereon at the site of the work specified. Any other use of this drawing, including without limitation any reproduction or alteration of this drawing, without prior written approval of Dunwody/Beeland, Architects, Inc. is prohibited.

MACON HOTEL
682 CHERRY STREET
MACON, GEORGIA

Revisions:	
△	10-18-19
△	11-20-20

Sheet Title:
Basement Plumbing
Plan - Water & Gas

Project #: 1821 Date: 8/12/2019

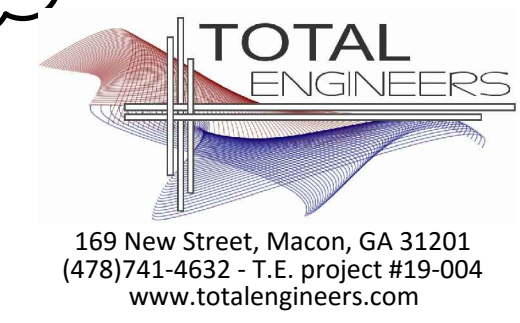

P2.0